
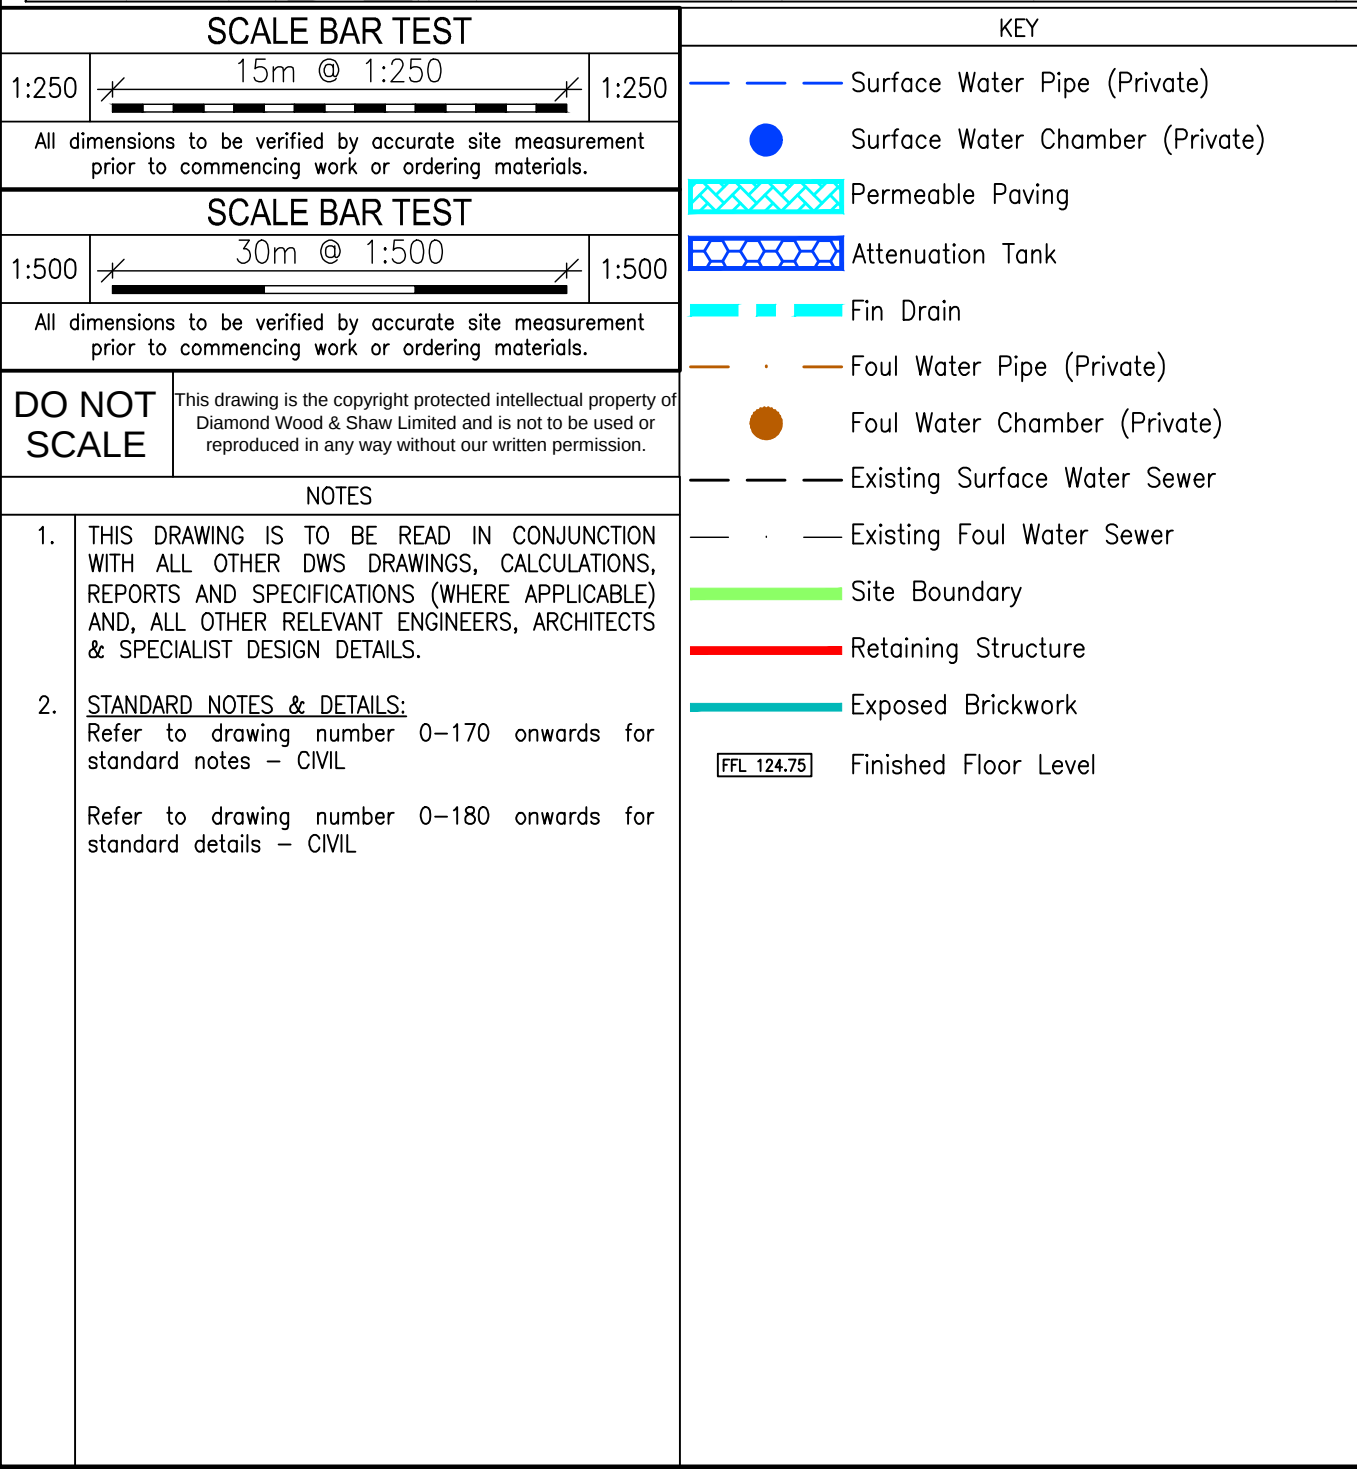
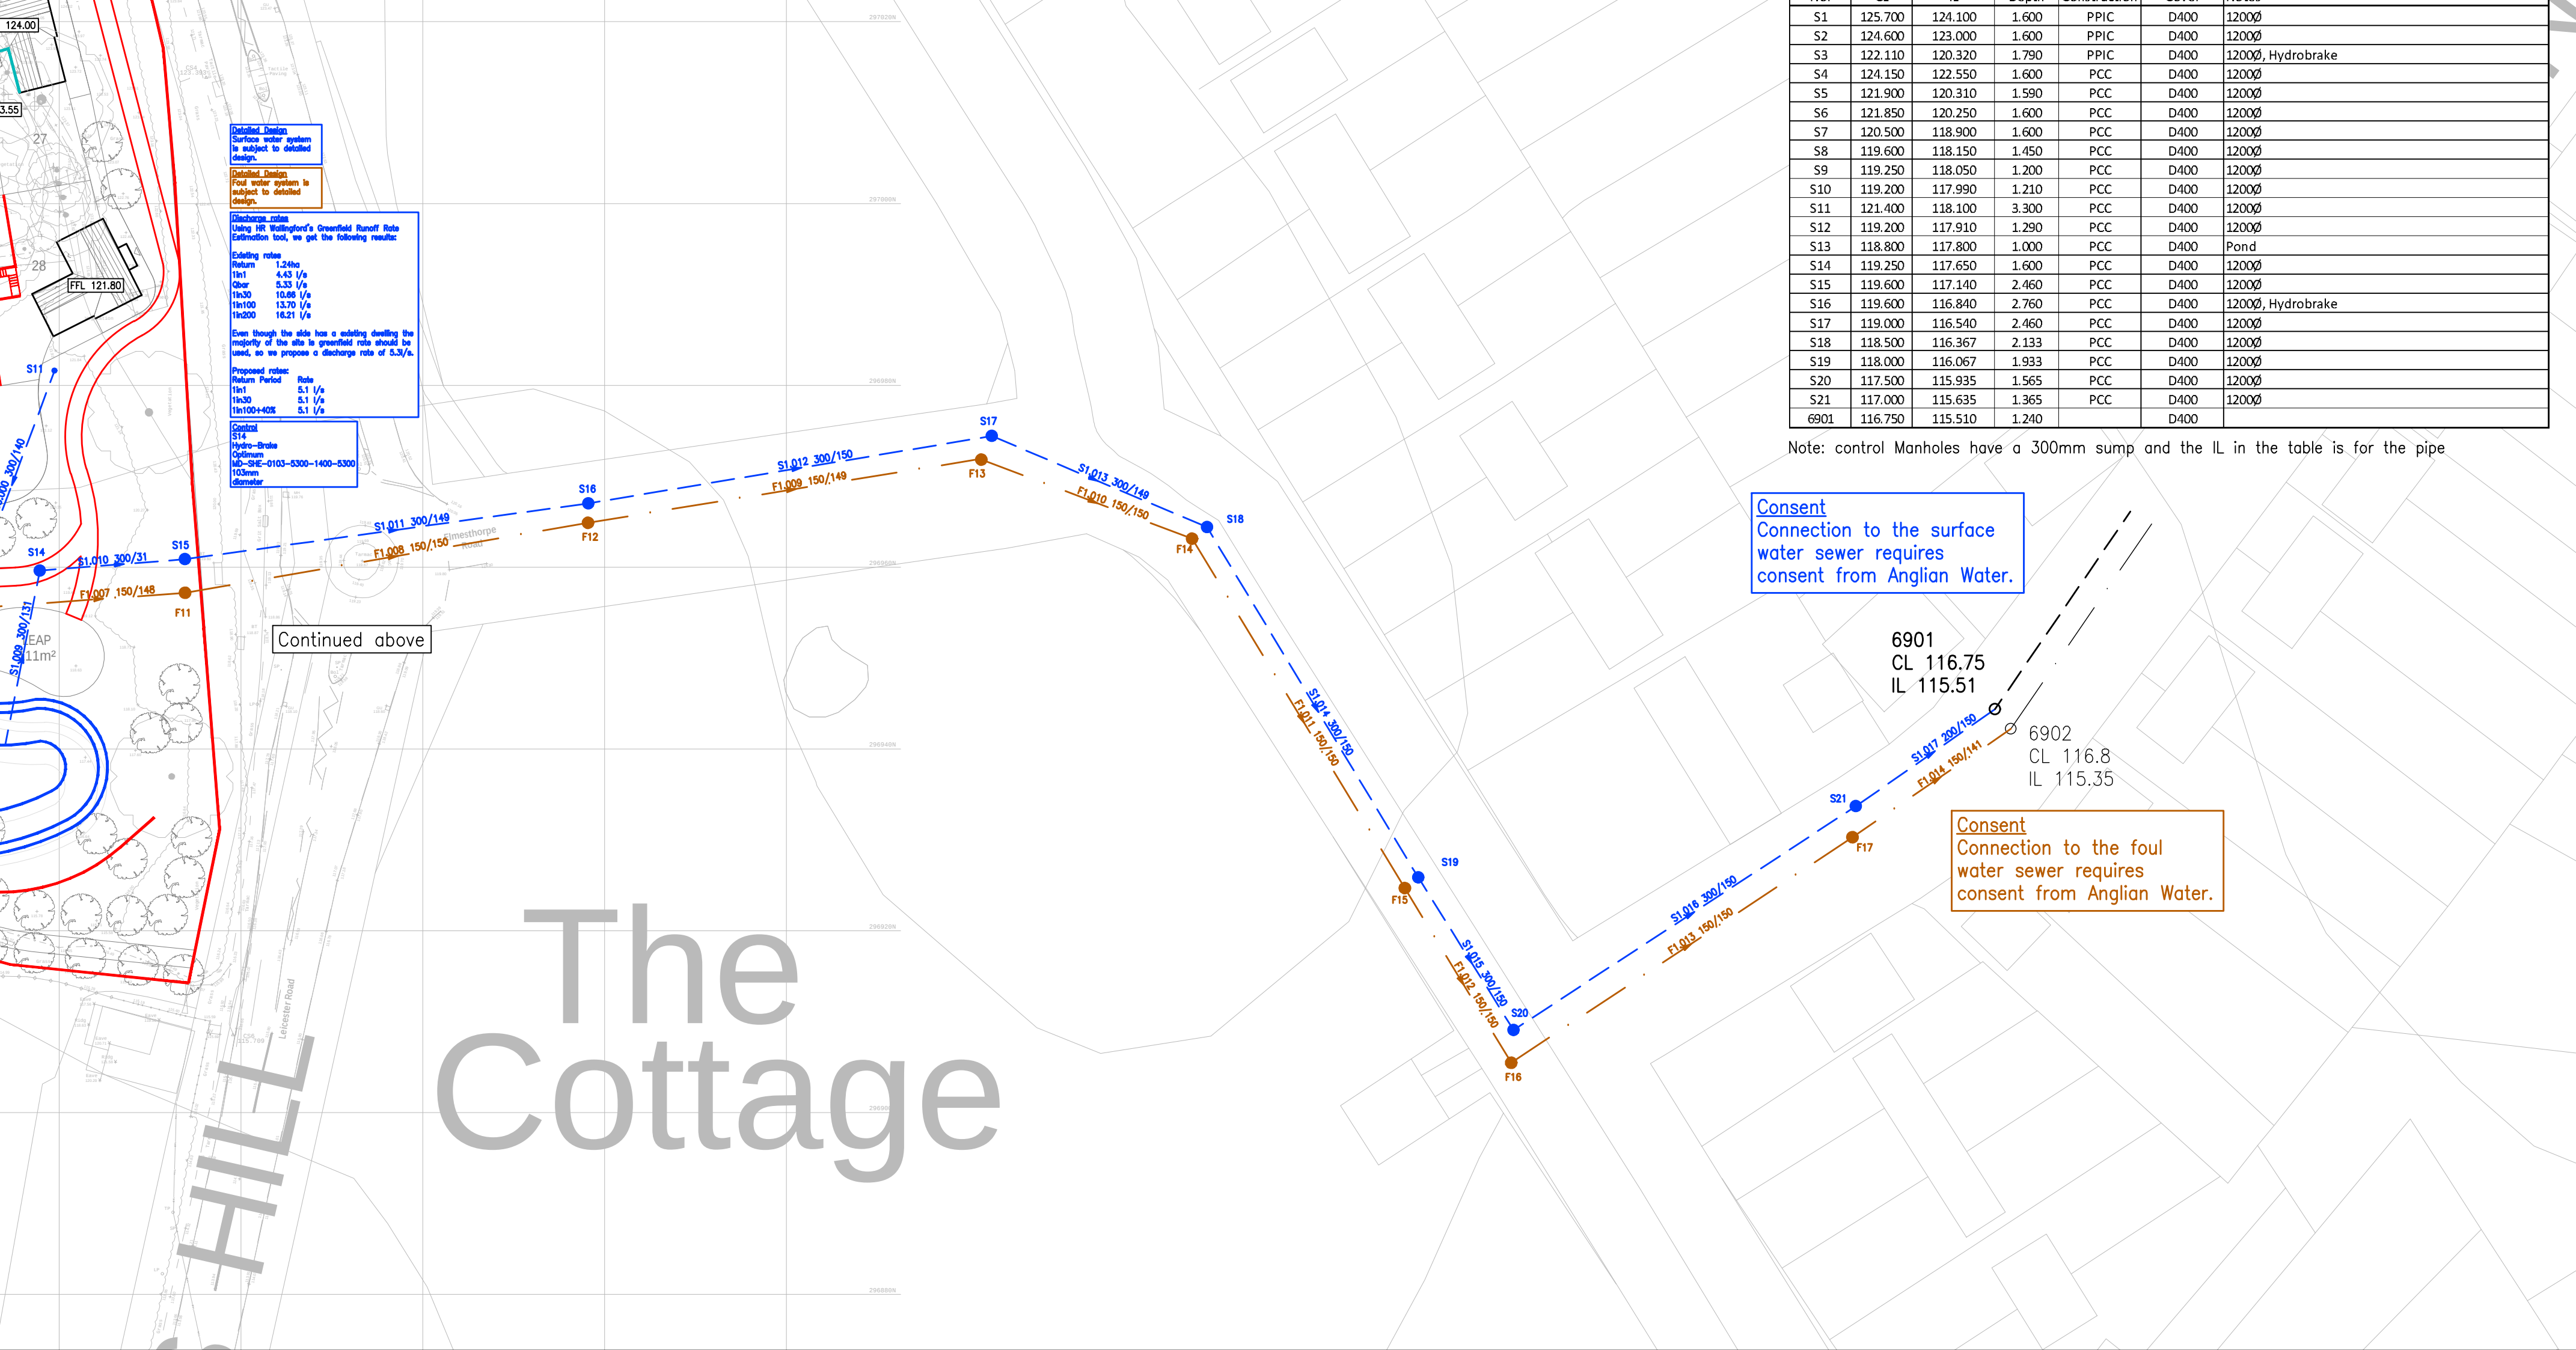


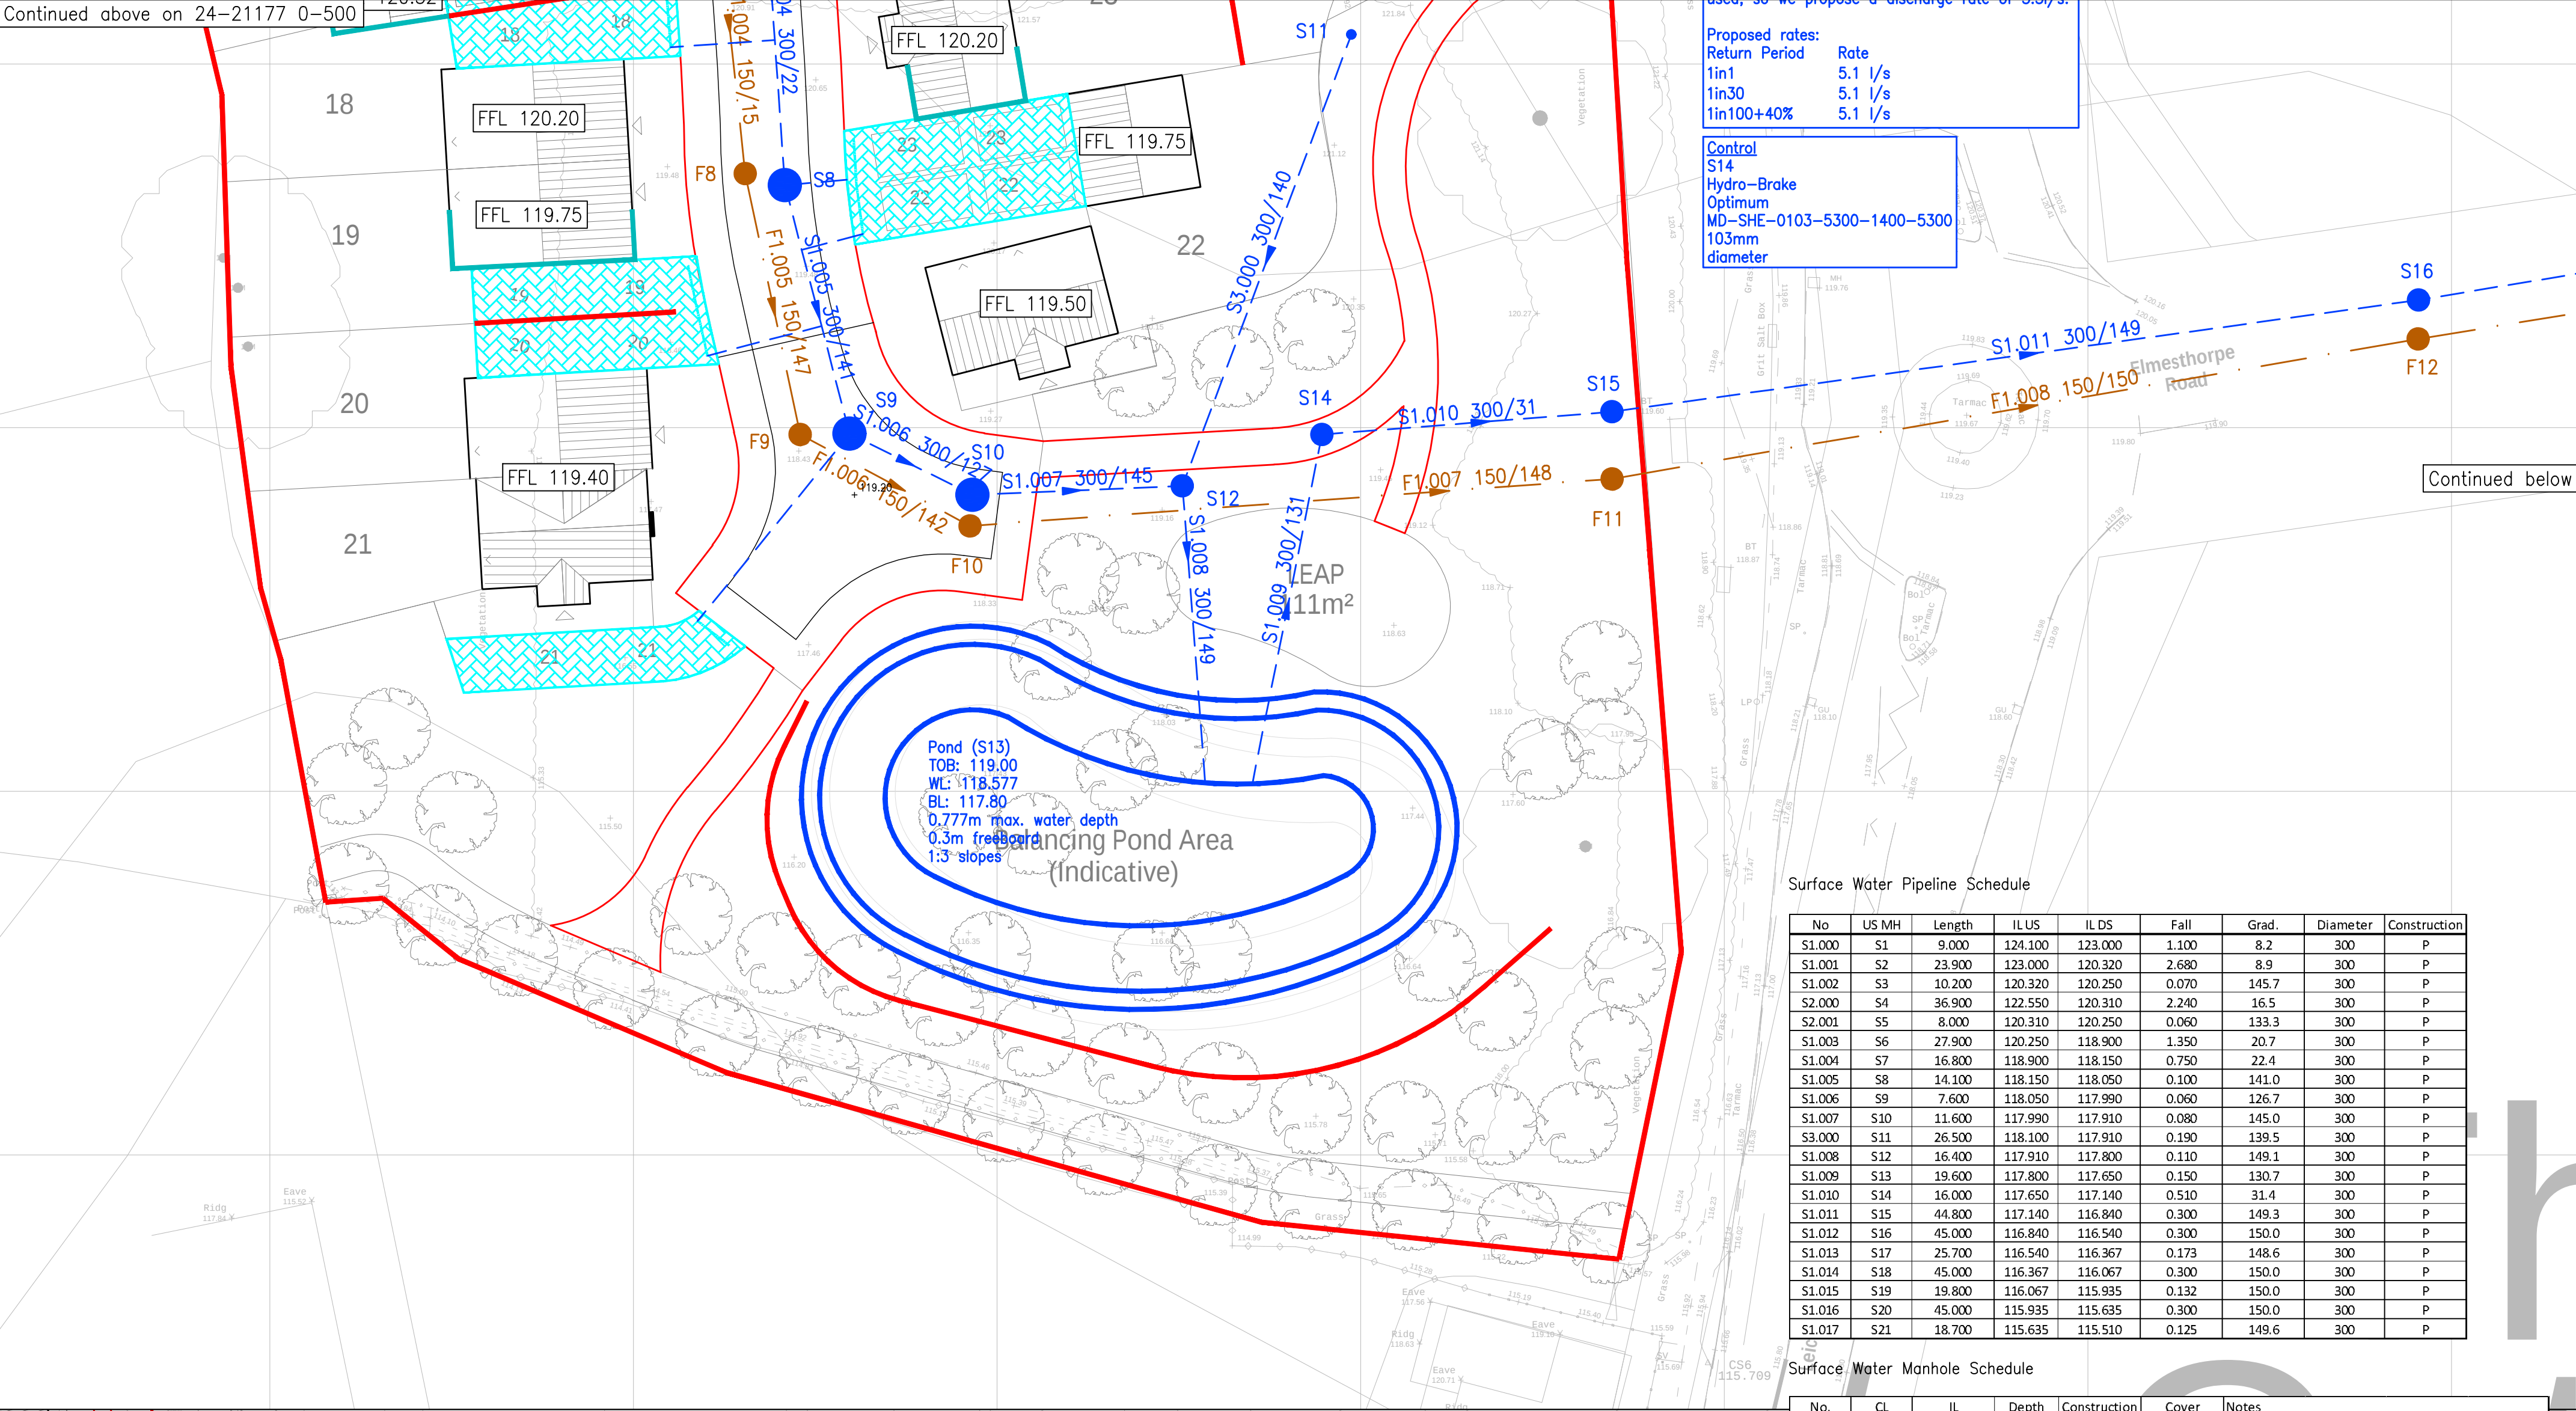

DRAINAGE LAYOUT - OUTFALL
Scale 1:250, 1:500

Foul Water Pipeline Schedule

No	US MH	Length	IL US	IL DS	Fall	Grad.	Diameter	Construction
F1.000	F1	9.490	123.500	122.700	0.800	11.9	150	P
F1.001	F2	28.540	122.700	120.005	2.695	10.6	150	P
F1.002	F3	7.480	120.005	119.950	0.055	136.0	150	P
F2.000	F4	23.550	122.100	120.025	2.075	11.3	150	P
F2.001	F5	10.740	120.025	119.950	0.075	143.2	150	P
F1.003	F6	25.240	119.950	118.620	1.330	19.0	150	P
F1.004	F7	18.070	118.620	117.425	1.195	15.1	150	P
F1.005	F8	14.670	117.425	117.325	0.100	146.7	150	P
F1.006	F9	10.610	117.325	117.250	0.075	141.5	150	P
F1.007	F10	35.410	117.250	117.010	0.240	147.5	150	P
F1.008	F11	45.000	117.010	116.710	0.300	150.0	150	P
F1.009	F12	43.830	116.710	116.415	0.295	148.6	150	P
F1.010	F13	24.760	116.415	116.250	0.165	150.1	150	P
F1.011	F14	45.000	116.250	115.950	0.300	150.0	150	P
F1.012	F15	22.500	115.950	115.800	0.150	150.0	150	P
F1.013	F16	45.000	115.800	115.500	0.300	150.0	150	P
F1.014	F17	21.120	115.500	115.350	0.150	140.8	150	P

Foul Water Manhole Schedule

No.	CL	IL	Depth	Construction	Cover	Notes
F1	125.700	123.500	2.200	PPIC	D400	450Ø
F2	124.600	122.700	1.900	PPIC	D400	1200Ø
F3	122.110	120.005	2.105	PPIC	D400	1200Ø
F4	124.000	122.100	1.900	PPIC	D400	1200Ø
F5	121.900	120.025	1.875	PPIC	D400	1200Ø
F6	121.850	119.950	1.900	PPIC	D400	1200Ø
F7	120.520	118.620	1.900	PPIC	D400	1200Ø
F8	119.600	117.425	2.175	PPIC	D400	1200Ø
F9	119.250	117.325	1.925	PPIC	D400	1200Ø
F10	119.200	117.250	1.950	PPIC	D400	1200Ø
F11	119.600	117.010	2.590	PPIC	D400	1200Ø
F12	119.600	116.710	2.890	PPIC	D400	1200Ø
F13	119.000	116.415	2.585	PPIC	D400	1200Ø
F14	118.500	116.250	2.250	PPIC	D400	1200Ø
F15	118.000	115.950	2.050	PPIC	D400	1200Ø
F16	117.500	115.800	1.700	PPIC	D400	1200Ø
F17	117.000	115.500	1.500	PPIC	D400	1200Ø
6902	116.800	115.350	1.450	Brick	D400	1200Ø

P3	LLFA comments addressed	09.07.25	LM
P2	Updated architectural layout	20.02.25	LM
P1	First issue	13.01.25	LM
Ref	Revision	Date	By

Issue

PRELIMINARY

DWS
Consulting Engineers

Diamond Wood & Shaw Limited
The Old School • Blaby Road • Enderby • Leicester • LE19 4AR
Tel 0116 284 8989 • Email mail@dwsd.co.uk

Project Title
LEICESTER ROAD
BARWELL

Drawn
LM

Engineer
LM

Checked
BP

Scale
1:250, 1:500 @ A1

Date
JAN 2025

Drawing Title
DRAINAGE LAYOUT - OUTFALL

Project No.
24-21177

Drawing No.
0-501

Revision
P3

BIM Code